




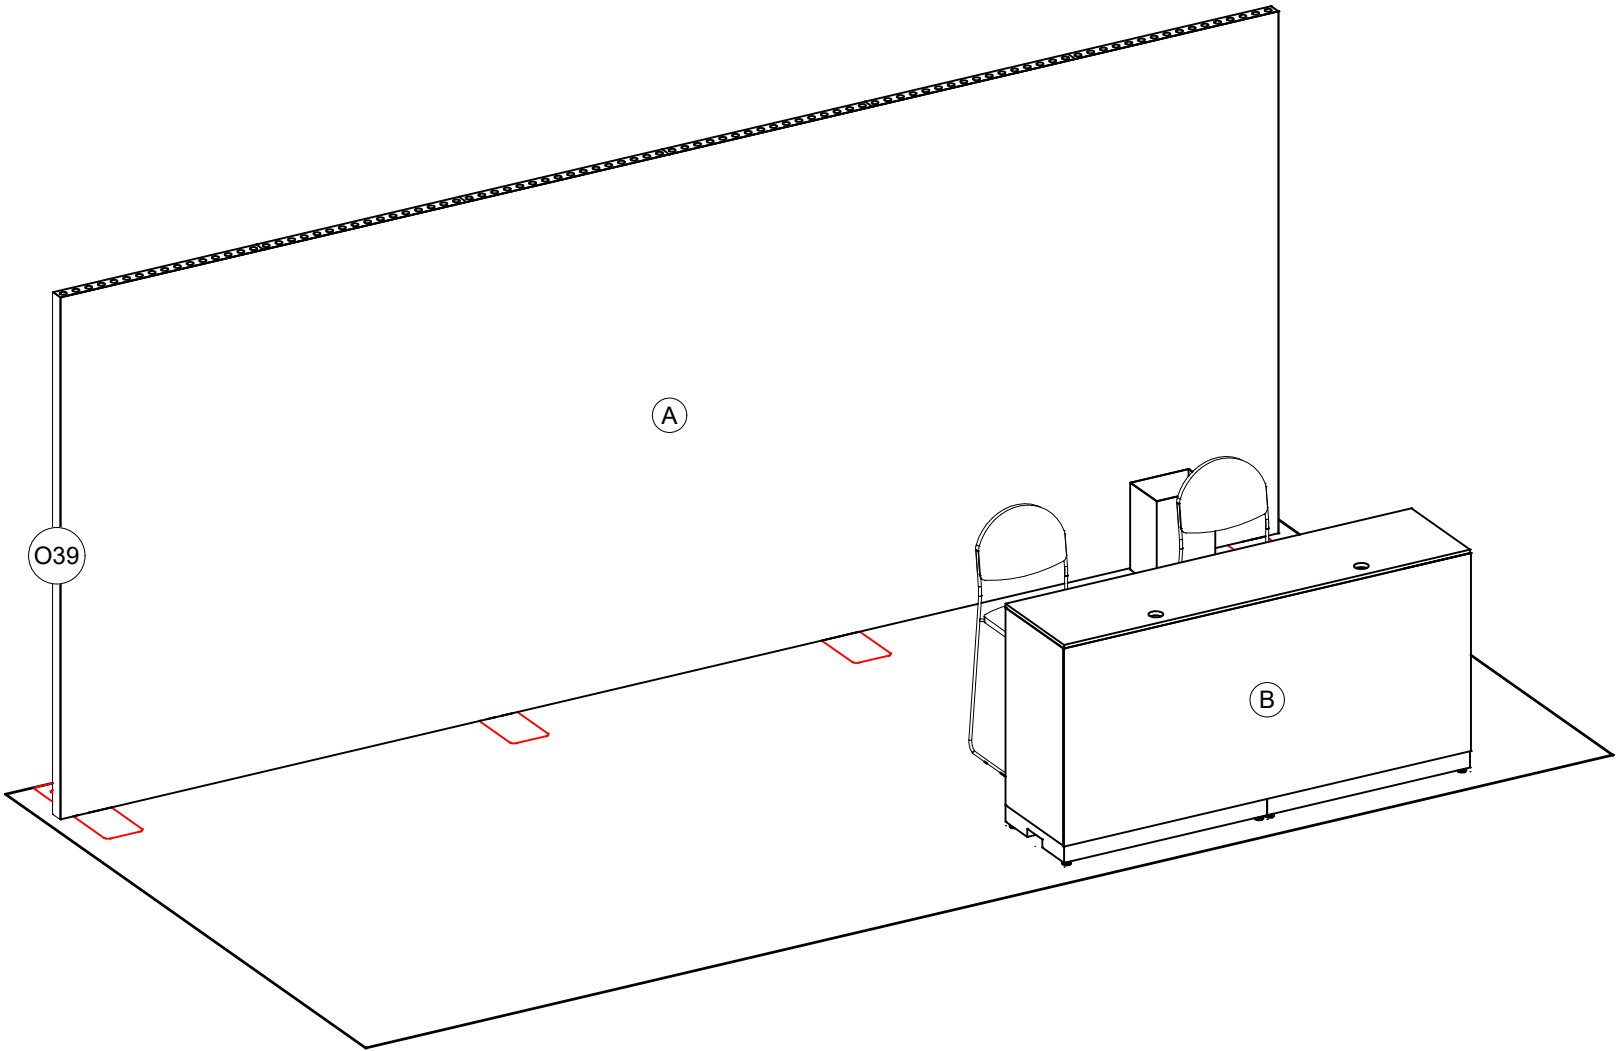


3D VIEW - 1

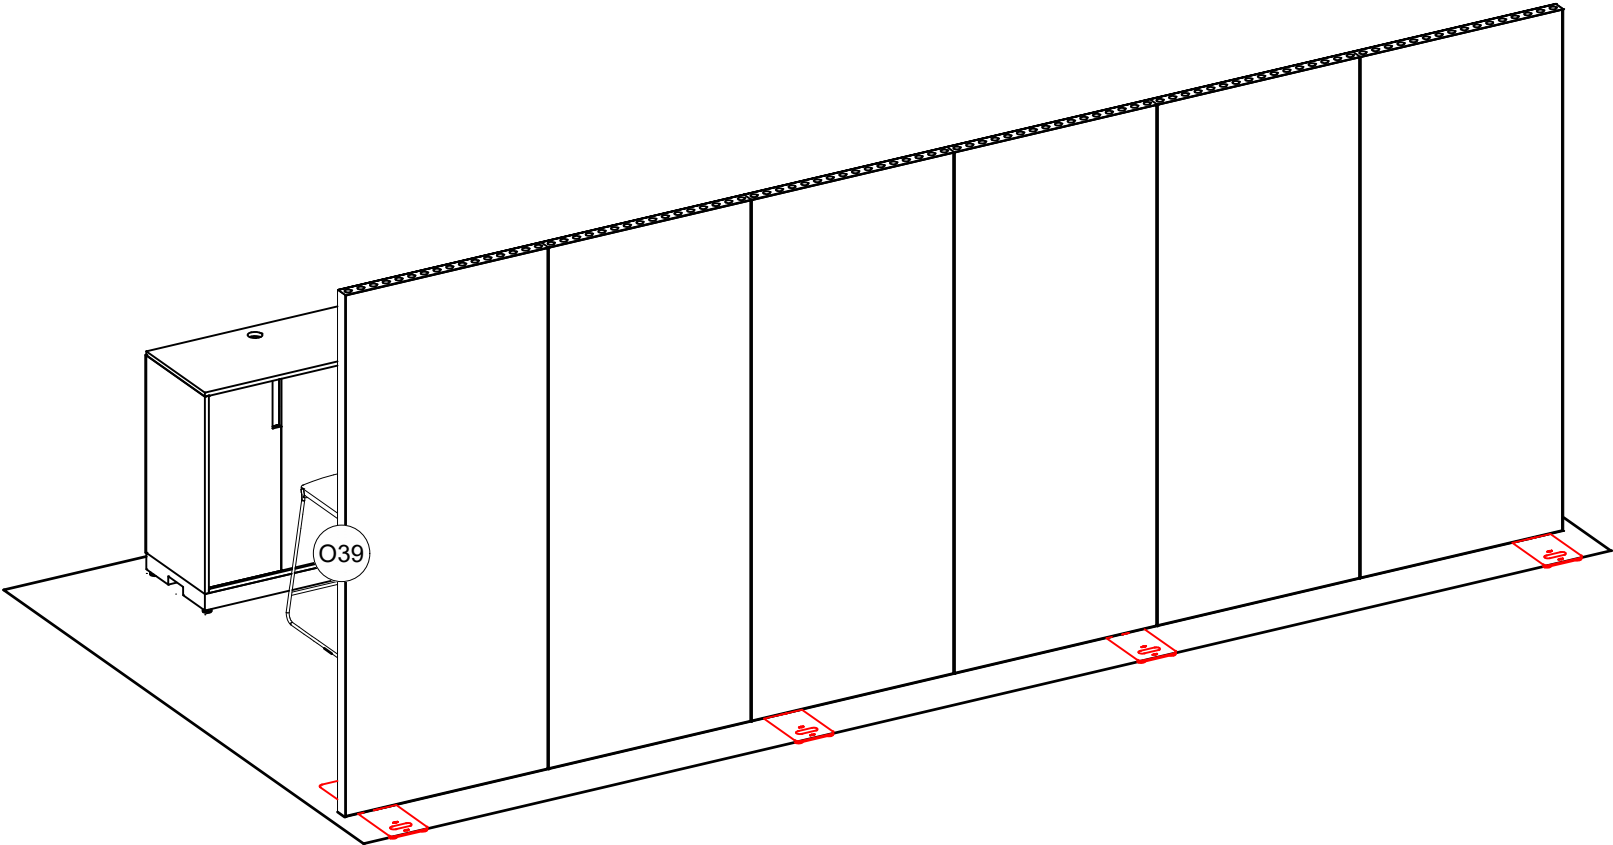


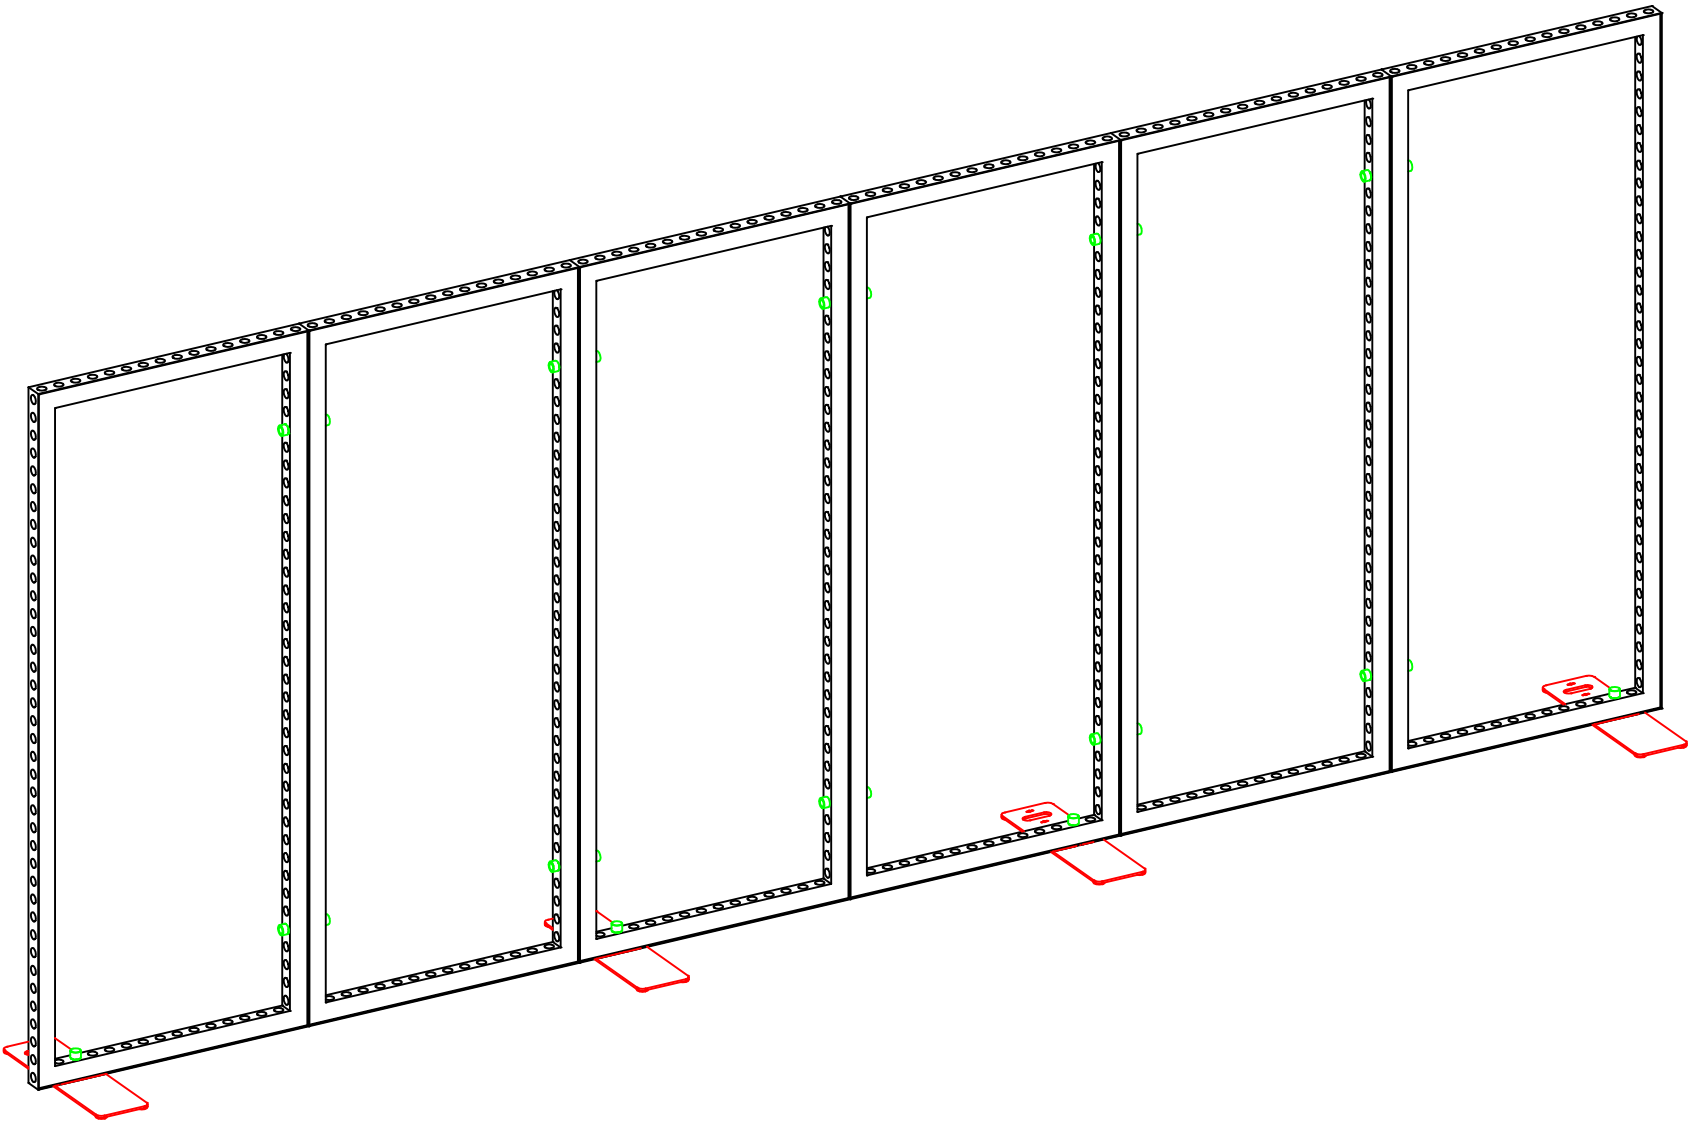


STRUCTURE VIEW

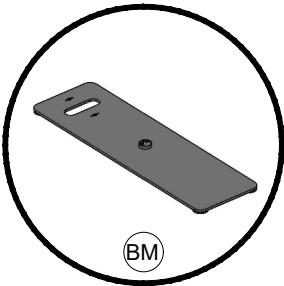


INLINE FLEX CONNECTION

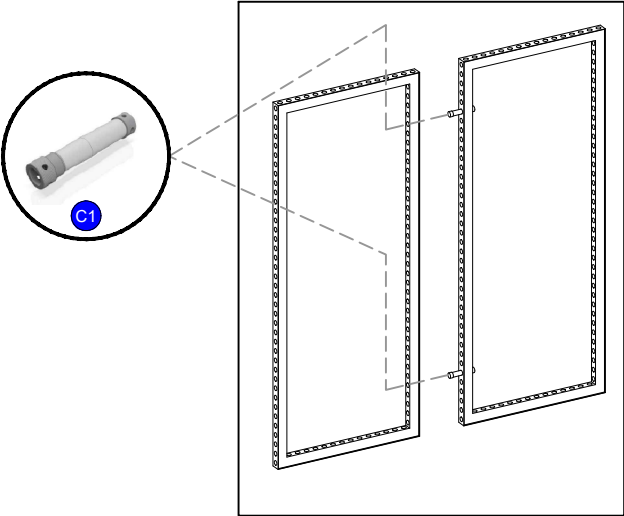

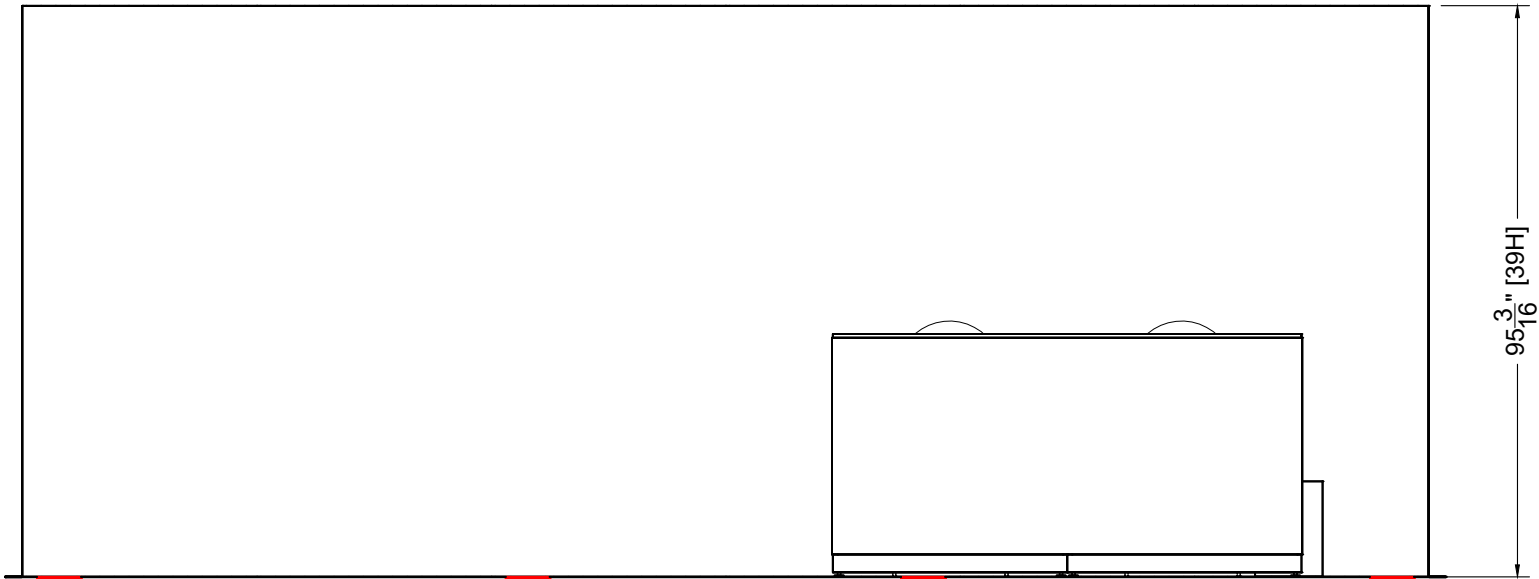

FRONT ELEVATION
Scale: 3/8" = 1'-0"

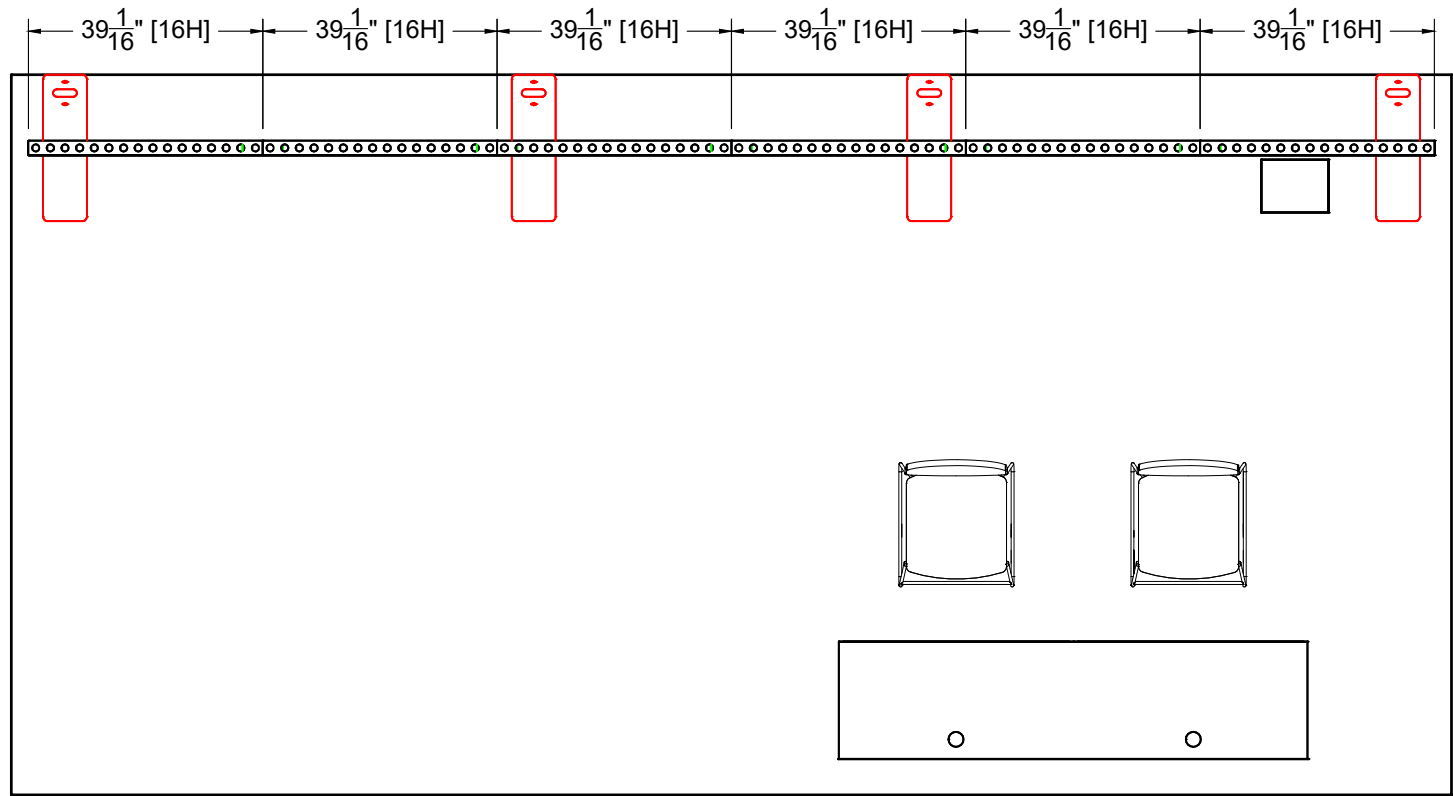

PLAN VIEW
Scale: 3/8" = 1'-0"

PRODUCTION-READY
DETAIL

10 x 20 Turnkey

TBD

Content Marketing World 2025

SAN DIEGO CONVENTION CENTER
SAN DIEGO, CA | 09/15/25 - 09/16/25

14658741

537148

EXHIBIT NAME / UNIT NAME

EXHIBIT # / UNIT LOCATION

EVENT NAME

EVENT FACILITY / DATES

PASSPORT LINE ITEM #

WORK TICKET #

JOB #

Pull List											
I.D.	Qty	Type	Size	Area (SqFt)	Part Number	Description	Material	Color	Notes	Low Inv.	Weight
	6	FLEX Frame-Straight	39-1/16" x 95-3/16" (39.062" x 95.188")		60400043	Straight Frame 16 Hole x 39 Hole	Aluminum	Silver	SF16390001		108.36
BM	4	FLEX Acc-Base Plate	7-5/16" x 24-7/16" x 0-7/16"		60440082	BASE PLATE MEDIUM	Steel	Silver			50.24
C1	10	FLEX Part-Connector	Standard		60440043	MANUAL CLAMP CONNECTOR	Aluminum	Silver	CO90120250132POM		3.70
C10	4	FLEX Part-Connector	Standard		60440047	MANUAL M8 PIN CONNECTOR	Aluminum	Silver	CO90120480066MKII		0.88
O39	2	Overlay Panel	2-7/16" x 95-3/16"		<<CUSTOM>>	Cover Profile 39 Hole	PVC 3MM	White			
A	1	FLEX Fabric Graphic	234-5/16" x 95-3/16" (234.312" x 95.188")	154.9	<<CUSTOM>>	234-5/16" x 95-3/16" FABRIC - GRAPHIC	Fabric	Graphic			
	6	Flex Insert	38-3/4" x 94-15/16" (38.75" x 94.938")	25.5	60160051	PVC INFILL FOR STRAIGHT FRAME 16 HOLE X 39 HOLE	PVC 3MM	White	w/ Female Velcro		75.36
	2	Barstool	22" x 18" x 46"		<<CUSTOM>>	Black Diamond Stool	Fabric	Gray			
	1	Furniture	11-1/4" x 8-7/8" x 15-7/8"		<<CUSTOM>>	Corrugated Wastebasket	Cardboard	Brown			
	2	MBS Cabinet	39-1/16" x 19-1/2" x 39-1/16"		60200004	MBS CABINET UNIT 1M X 1/2M X 1M	Laminate	White			
B	1	MBS Cabinet Graphic	78-3/8" x 36-1/8"	19.7	20600011	MBS CABINET OVERLAY GRAPHIC 78.375" X 36.125"	PVC 2MM	Graphic			
	2	MBS Cabinet Insert	38-1/8" x 0-1/8" x 35-3/4"		60200073	MBS PVC PANEL - WHITE - 38.125" X 35.75"	PVC 3MM	White			
	1	MBS Countertop	78-1/8" x 19-1/2" x 0-11/16"		60200033	MBS TOP - STANDARD 2M X 1/2M X 3/4"	Starboard 3/4	White			
	2	MBS Countertop - INV	39-1/16" x 19-1/2" x 0-11/16"		60200032	MBS TOP - STANDARD 1M X 1/2M X 3/4"	Starboard 3/4	White	For EIS inventory tracking		
			Total Area:	200.10						Total Weight:	238.54

Electronics are
placeholders. Consult
w_Sales or AV for details
and availability

Freeman

Business Development Mgr:
Scot Sweazy

Client Solutions Mgr:
SAN DIEGO

Detailer:
K Krippene



Last Saved:
4/4/2025 1:18 PM

Revision:
A

These original concepts and designs are sole property of FREEMAN. Any reproduction or use is prohibited without written consent of FREEMAN. © Copyright 2025 FREEMAN

Vault File Name: CMW25 10x20 Turnkey L14658741 DET.dwg

4 of 5

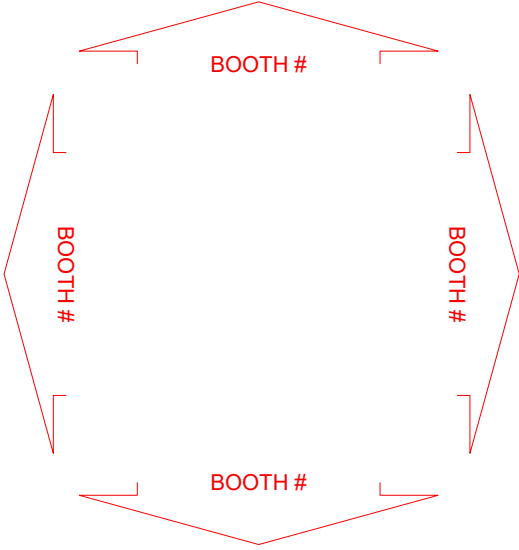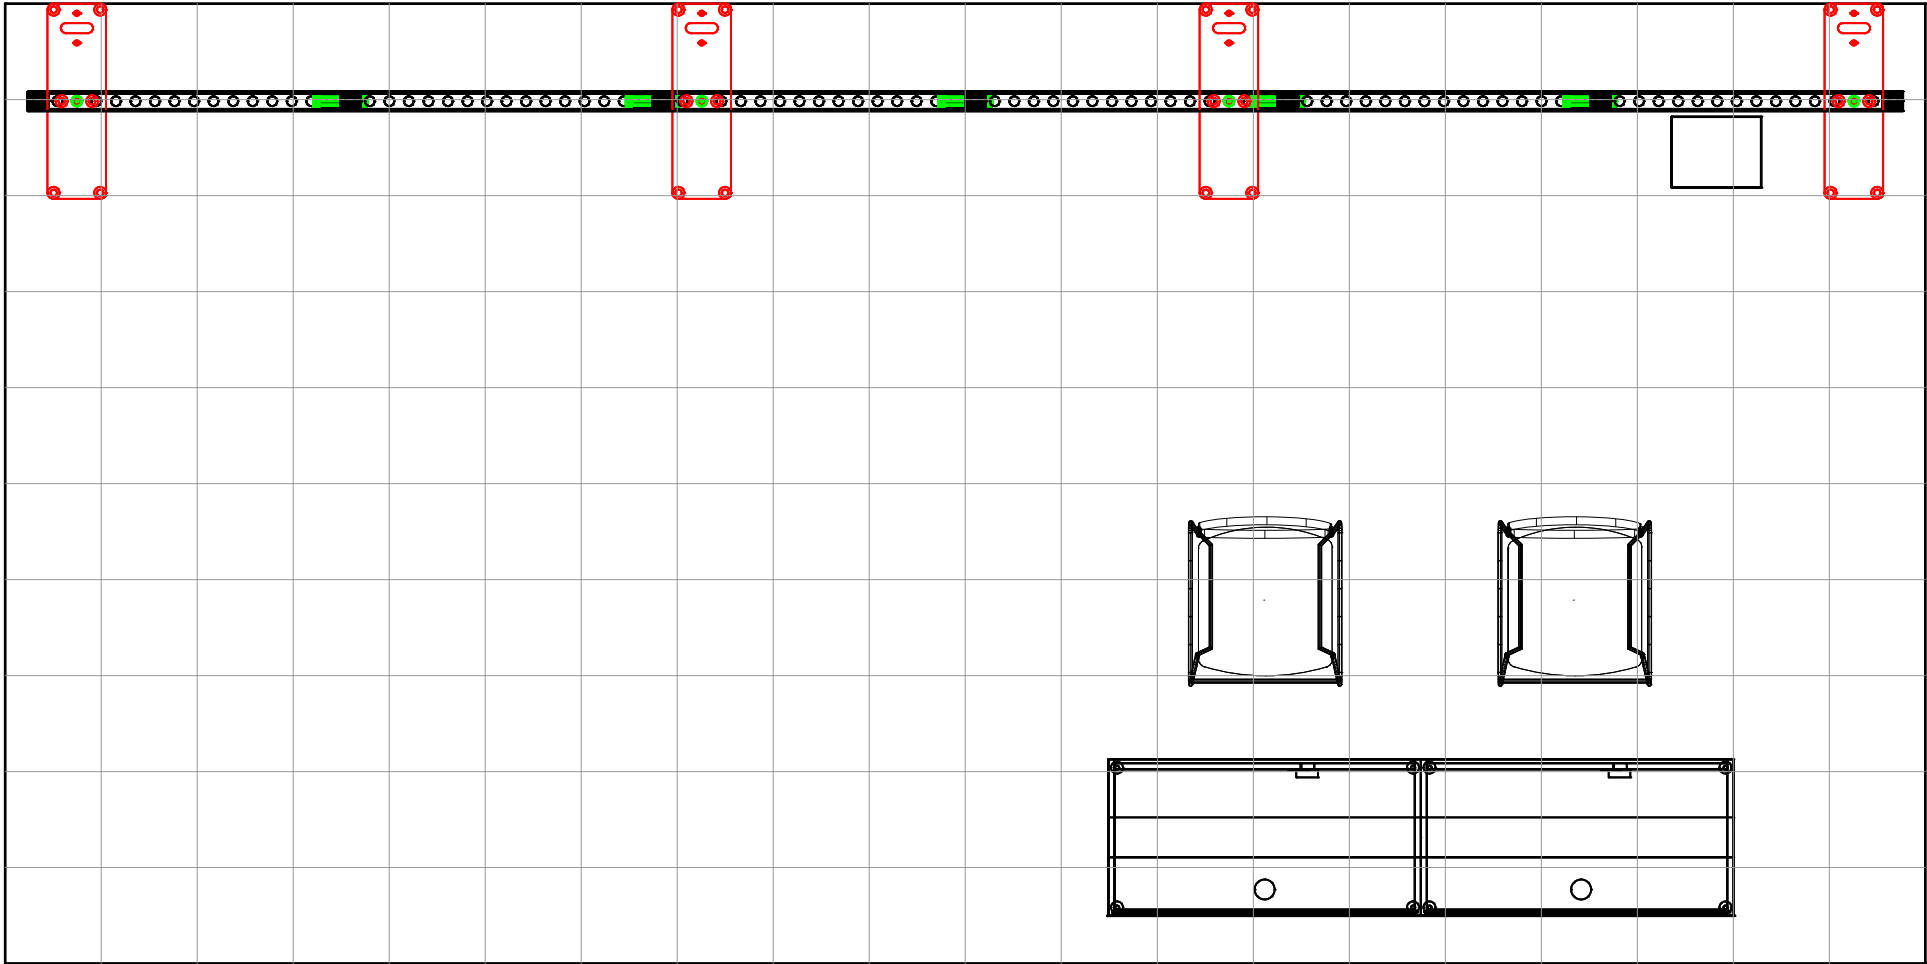

ELECTRICAL LAYOUT
Scale: 1/2" = 1'-0"

UTILITIES LEGEND	
QTY	DESCRIPTION
--	5A - 120V, 5 Amp
--	10A - 120V, 10 Amp
--	▽ - INTERNET LINE